


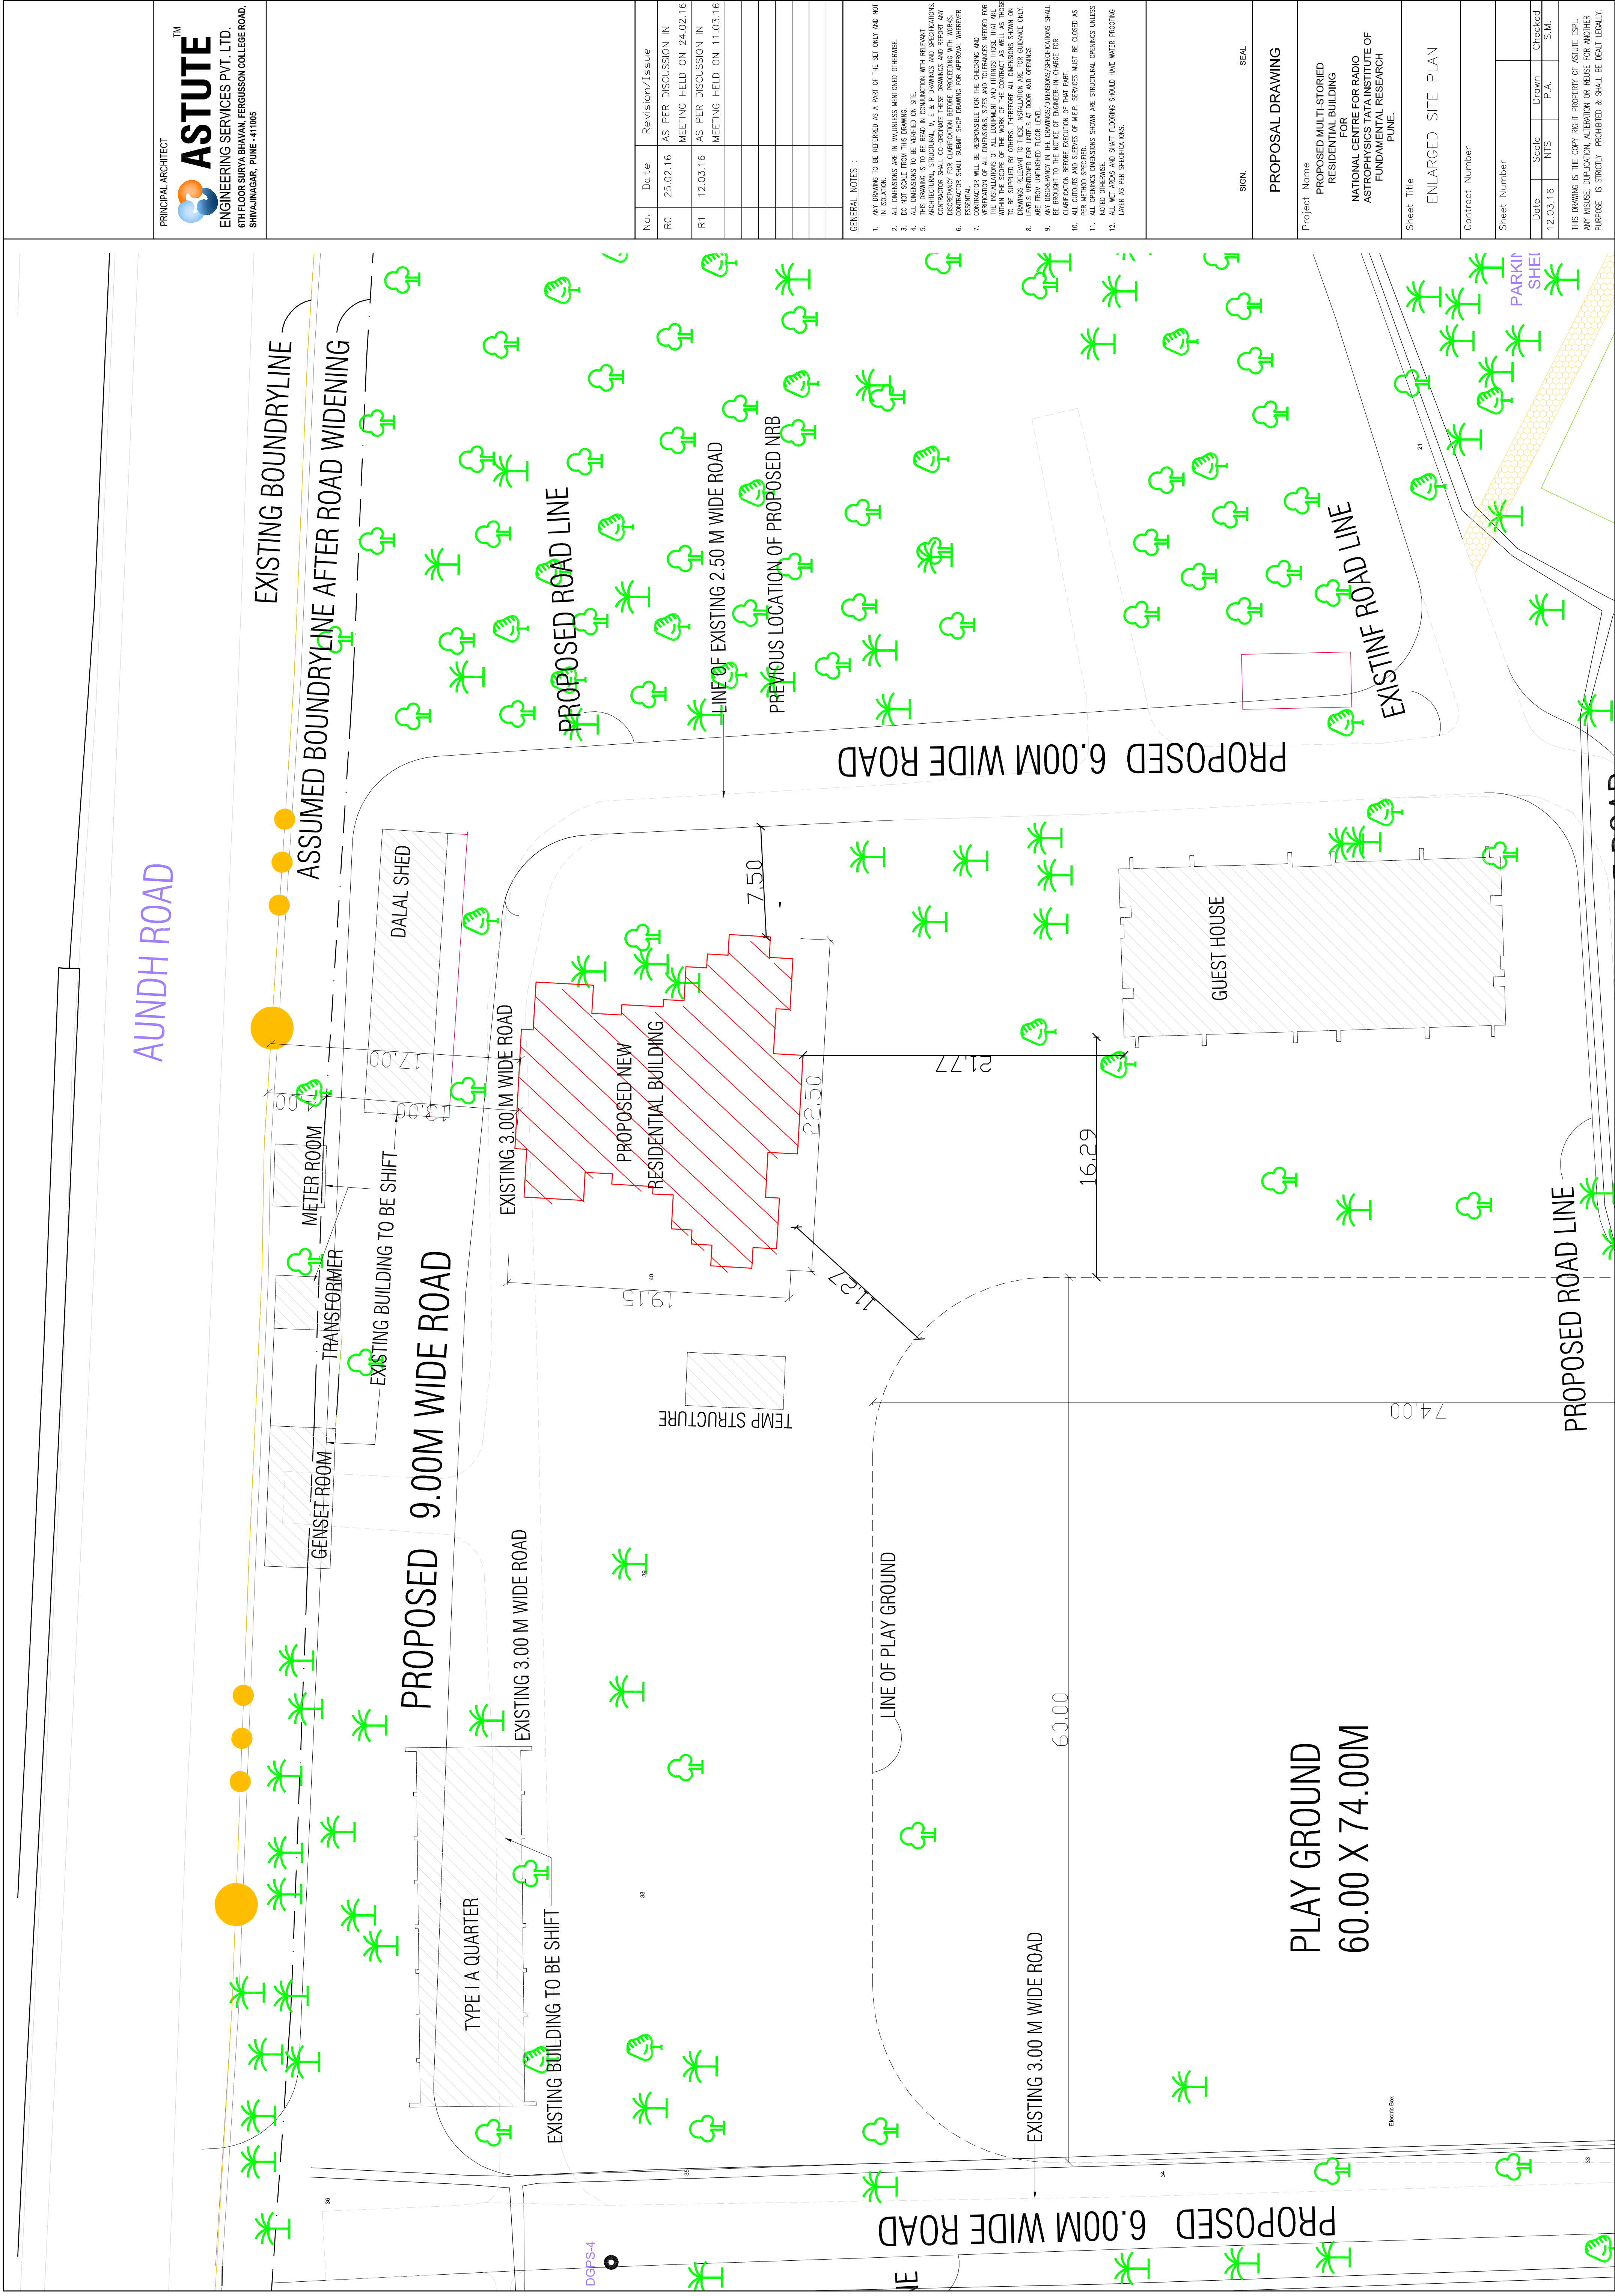

PRINCIPAL ARCHITECT

ASTUTETM

ENGINEERING SERVICES PVT. LTD.

6TH FLOOR SURYA BHAVAN, FERGUSSON COLLEGE ROAD,
SHIVAJINAGAR, PUNE - 411005

No.	Date	Revision/Issue
R0	25.02.16	AS PER DISCUSSION IN MEETING HELD ON 24.02.16
R1	12.03.16	AS PER DISCUSSION IN MEETING HELD ON 11.03.16

GENERAL NOTES :

- [illegible]

SIGN. _____ SEAL _____

PROPOSAL DRAWING

Project Name
PROPOSED MULTI-STORIED
RESIDENTIAL BUILDING
FOR
NATIONAL CENTRE FOR RADIO
ASTROPHYSICS TATA INSTITUTE OF
FUNDAMENTAL RESEARCH
PUNE.

Sheet Title
ENLARGED SITE PLAN

Contract Number

Sheet Number	
12.03.16	Date Scale Drawn Checked NTS P.A. S.M.

THIS DRAWING IS THE COPY RIGHT PROPERTY OF ASTUTE ESPL.
ANY MISUSE, DUPLICATION, ALTERATION OR REUSE FOR ANOTHER
PURPOSE IS STRICTLY PROHIBITED & SHALL BE DEALT LEGALLY.